


# VA NEW JERSEY HEALTH CARE SYSTEM LYONS CAMPUS

151 KNOLLCROFT RD  
LYONS, NJ 07939

## BATHROOM #1 PLUMBING REPAIR CONTRACT NO. VA243-16-C-0007

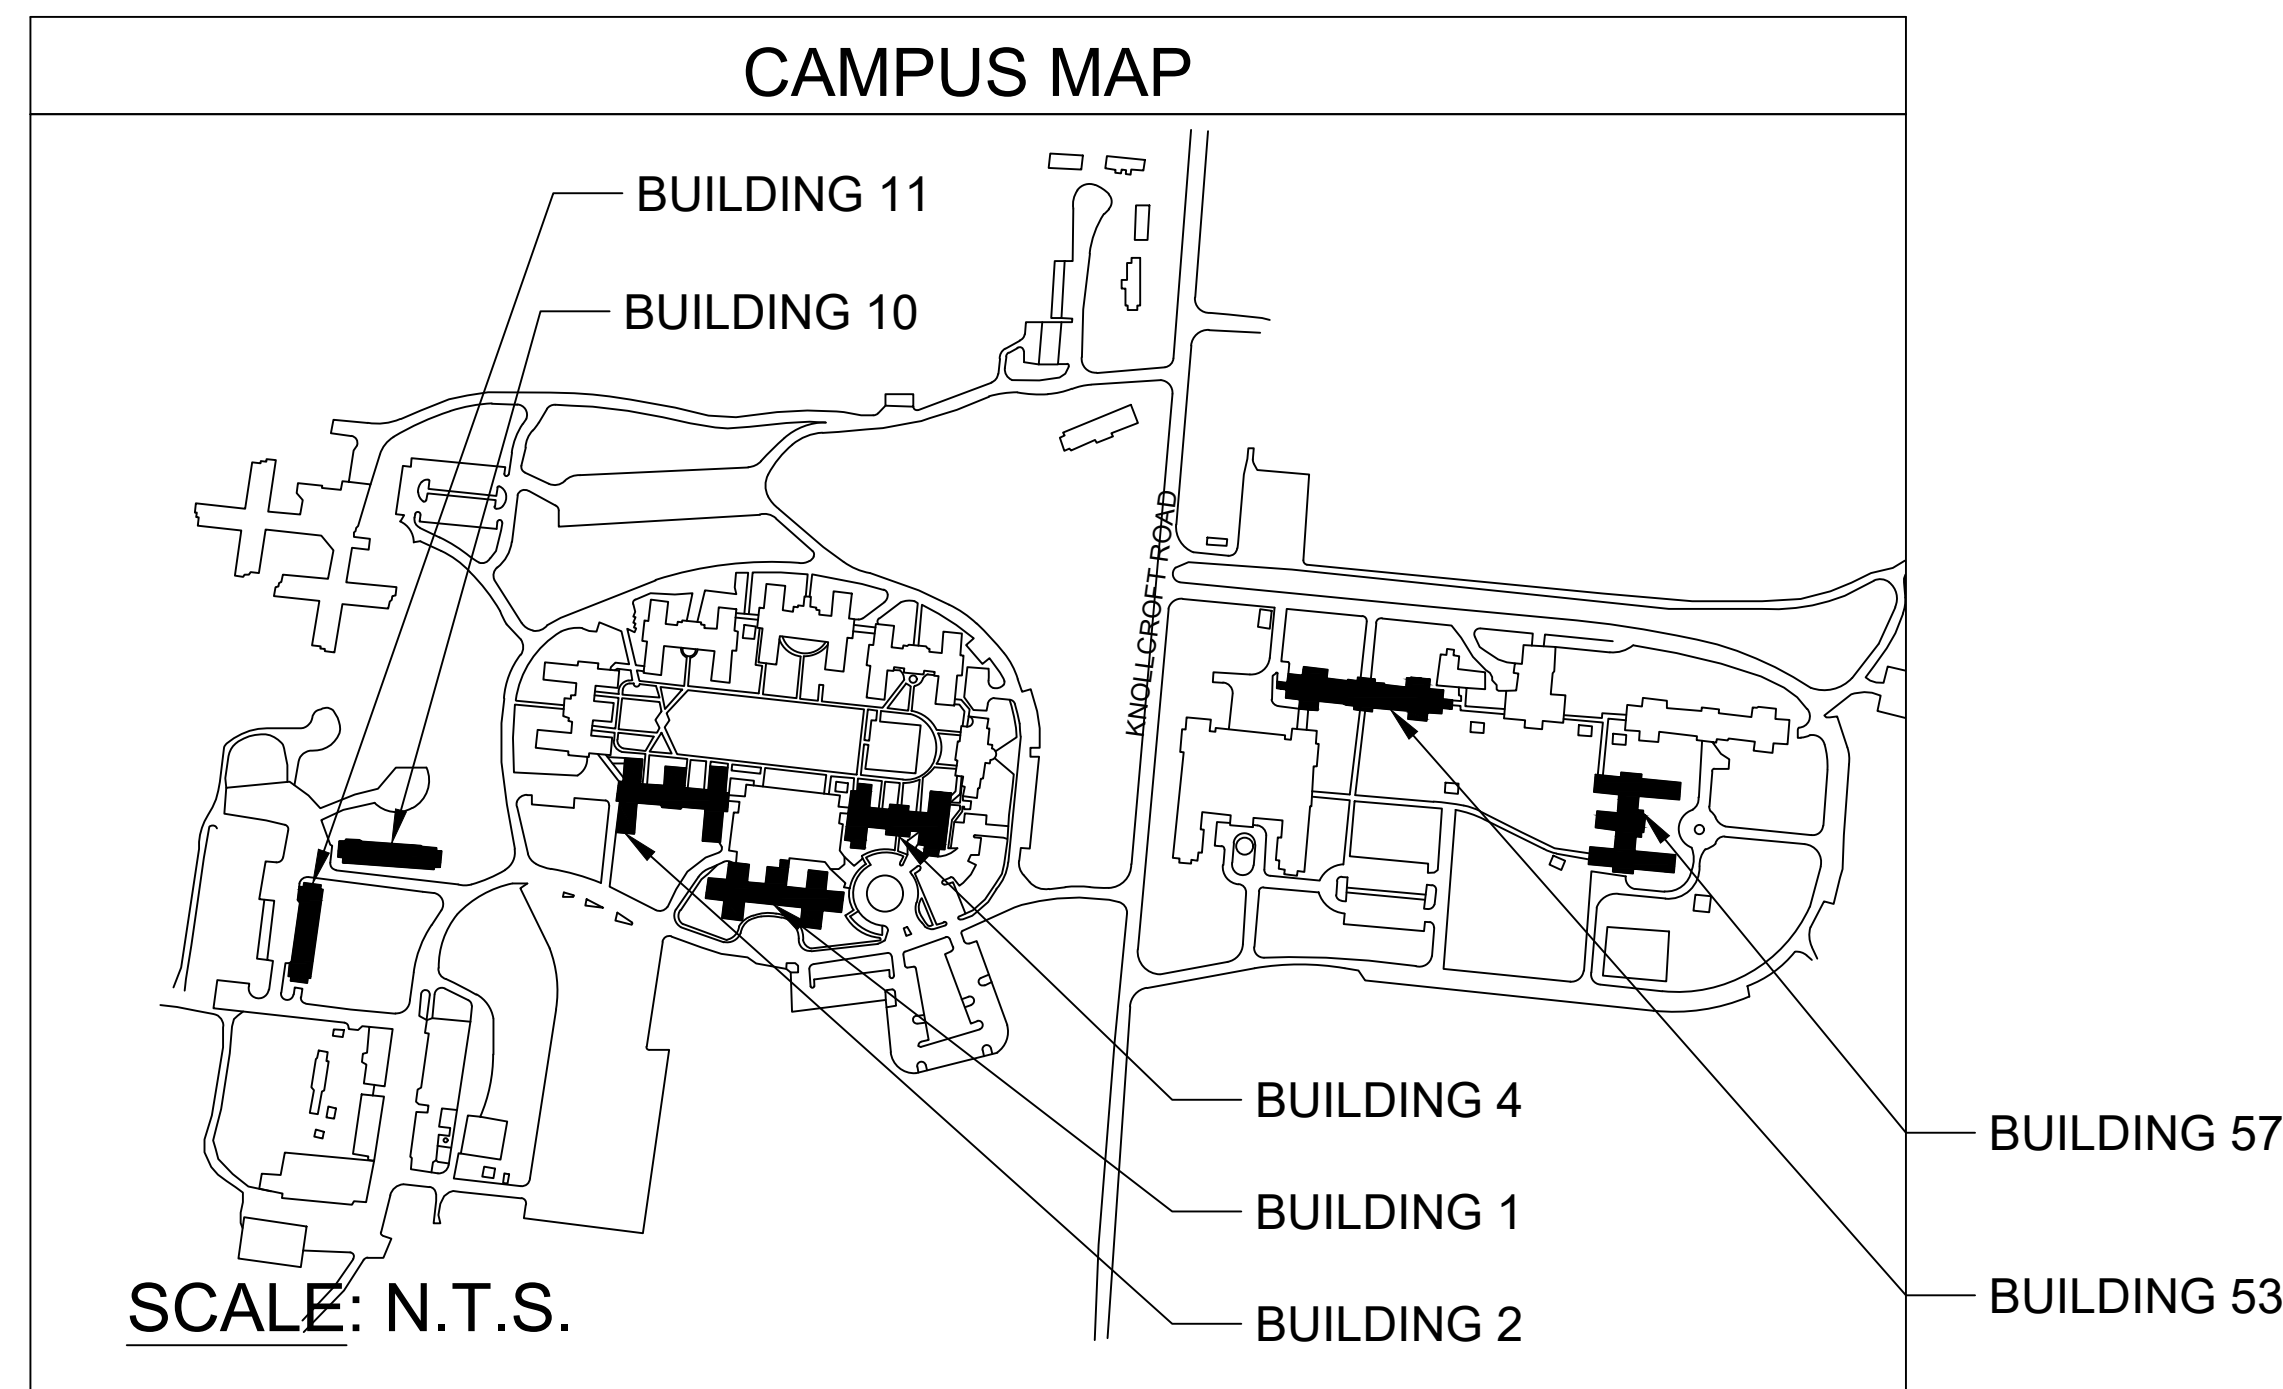

### DRAWING INDEX

DRAWING TITLE	SHEET NUMBER	DRAWING TITLE	SHEET NUMBER	DRAWING TITLE	SHEET NUMBER	DRAWING TITLE	SHEET NUMBER	DRAWING TITLE	SHEET NUMBER
ARCHITECTURAL NOTES / DETAILS	D-A1	BUILDING 11 EXISTING/PROPOSED FLOOR PLANS	11-A1	BUILDING 53 EXISTING/PROPOSED FLOOR PLANS	53-A19	BUILDING 2 ELECTRICAL LAYOUT	2-E1	BUILDING 57 ELECTRICAL LAYOUT	57-E3
DOOR AND SIGNAGE SCHEDULE	D-A2	BUILDING 11 EXISTING/PROPOSED FLOOR PLANS	11-A2	BUILDING 53 EXISTING/PROPOSED FLOOR PLANS	53-A20	BUILDING 2 ELECTRICAL LAYOUT	2-E2	BUILDING 57 ELECTRICAL LAYOUT	57-E4
DOOR AND SIGNAGE SCHEDULE	D-A3	BUILDING 11 EXISTING/PROPOSED FLOOR PLANS	11-A3	BUILDING 53 EXISTING/PROPOSED FLOOR PLANS	53-A21	BUILDING 4 ELECTRICAL LAYOUT	4-E1	PLUMBING NOTES / DETAILS	D-P1
BUILDING 1 EXISTING/PROPOSED FLOOR PLANS	1-A1	BUILDING 11 EXISTING/PROPOSED FLOOR PLANS	11-A4	BUILDING 53 EXISTING/PROPOSED FLOOR PLANS	53-A22	BUILDING 10 ELECTRICAL LAYOUT	10-E1	BUILDING 1 PROPOSED PLUMBING PLANS	1-P1
BUILDING 1 EXISTING/PROPOSED FLOOR PLANS	1-A2	BUILDING 53 EXISTING/PROPOSED FLOOR PLANS	53-A1	BUILDING 53 EXISTING/PROPOSED FLOOR PLANS	53-A23	BUILDING 10 ELECTRICAL LAYOUT	10-E2	BUILDING 1 PROPOSED PLUMBING PLANS	1-P2
BUILDING 1 EXISTING/PROPOSED FLOOR PLANS	1-A3	BUILDING 53 EXISTING/PROPOSED FLOOR PLANS	53-A2	BUILDING 53 EXISTING/PROPOSED FLOOR PLANS	53-A24	BUILDING 11 ELECTRICAL LAYOUT	11-E1	BUILDING 2 PROPOSED PLUMBING PLANS	2-P1
BUILDING 1 EXISTING/PROPOSED FLOOR PLANS	1-A4	BUILDING 53 EXISTING/PROPOSED FLOOR PLANS	53-A3	BUILDING 53 EXISTING/PROPOSED FLOOR PLANS	53-A25	BUILDING 11 ELECTRICAL LAYOUT	11-E2	BLDG.S 4/10 PROPOSED PLUMBING PLANS	4-P1/10-P1
BUILDING 1 EXISTING/PROPOSED FLOOR PLANS	1-A5	BUILDING 53 EXISTING/PROPOSED FLOOR PLANS	53-A4	BUILDING 53 EXISTING/PROPOSED FLOOR PLANS	53-A26	BUILDING 53 ELECTRICAL LAYOUT	53-E1	BUILDING 11 PROPOSED PLUMBING PLANS	11-P1
BUILDING 1 EXISTING/PROPOSED FLOOR PLANS	1-A6	BUILDING 53 EXISTING/PROPOSED FLOOR PLANS	53-A5	BUILDING 57 EXISTING/PROPOSED FLOOR PLANS	57-A1	BUILDING 53 ELECTRICAL LAYOUT	53-E2	BUILDING 53 PROPOSED PLUMBING PLANS	53-P1
BUILDING 1 EXISTING/PROPOSED FLOOR PLANS	1-A7	BUILDING 53 EXISTING/PROPOSED FLOOR PLANS	53-A6	BUILDING 57 EXISTING/PROPOSED FLOOR PLANS	57-A2	BUILDING 53 ELECTRICAL LAYOUT	53-E3	BUILDING 53 PROPOSED PLUMBING PLANS	53-P2
BUILDING 1 EXISTING/PROPOSED FLOOR PLANS	1-A8	BUILDING 53 EXISTING/PROPOSED FLOOR PLANS	53-A7	BUILDING 57 EXISTING/PROPOSED FLOOR PLANS	57-A3	BUILDING 53 ELECTRICAL LAYOUT	53-E4	BUILDING 53 PROPOSED PLUMBING PLANS	53-P3
BUILDING 1 EXISTING/PROPOSED FLOOR PLANS	1-A9	BUILDING 53 EXISTING/PROPOSED FLOOR PLANS	53-A8	BUILDING 57 EXISTING/PROPOSED FLOOR PLANS	57-A4	BUILDING 53 ELECTRICAL LAYOUT	53-E5	BUILDING 53 PROPOSED PLUMBING PLANS	53-P4
BUILDING 1 EXISTING/PROPOSED FLOOR PLANS	1-A10	BUILDING 53 EXISTING/PROPOSED FLOOR PLANS	53-A9	BUILDING 57 EXISTING/PROPOSED FLOOR PLANS	57-A5	BUILDING 53 ELECTRICAL LAYOUT	53-E6	BUILDING 53 PROPOSED PLUMBING PLANS	53-P5
BUILDING 2 EXISTING/PROPOSED FLOOR PLANS	2-A1	BUILDING 53 EXISTING/PROPOSED FLOOR PLANS	53-A10	BUILDING 57 EXISTING/PROPOSED FLOOR PLANS	57-A6	BUILDING 53 ELECTRICAL LAYOUT	53-E7	BUILDING 53 PROPOSED PLUMBING PLANS	53-P6
BUILDING 2 EXISTING/PROPOSED FLOOR PLANS	2-A2	BUILDING 53 EXISTING/PROPOSED FLOOR PLANS	53-A11	BUILDING 57 EXISTING/PROPOSED FLOOR PLANS	57-A7	BUILDING 53 ELECTRICAL LAYOUT	53-E8	BUILDING 57 PROPOSED PLUMBING PLANS	57-P1
BUILDING 2 EXISTING/PROPOSED FLOOR PLANS	2-A3	BUILDING 53 EXISTING/PROPOSED FLOOR PLANS	53-A12	BUILDING 57 EXISTING/PROPOSED FLOOR PLANS	57-A8	BUILDING 53 ELECTRICAL LAYOUT	53-E9	BUILDING 57 PROPOSED PLUMBING PLANS	57-P2
BUILDING 2 EXISTING/PROPOSED FLOOR PLANS	2-A4	BUILDING 53 EXISTING/PROPOSED FLOOR PLANS	53-A13	ELECTRICAL / MECHANICAL NOTES / DETAILS	D-E1	BUILDING 53 ELECTRICAL LAYOUT	53-E10	BUILDING 57 PROPOSED PLUMBING PLANS	57-P3
BUILDING 2 EXISTING/PROPOSED FLOOR PLANS	2-A5	BUILDING 53 EXISTING/PROPOSED FLOOR PLANS	53-A14	BUILDING 1 ELECTRICAL LAYOUT	1-E1	BUILDING 53 ELECTRICAL LAYOUT	53-E11	BUILDING 57 PROPOSED PLUMBING PLANS	57-P4
BUILDING 4 EXISTING/PROPOSED FLOOR PLANS	4-A1	BUILDING 53 EXISTING/PROPOSED FLOOR PLANS	53-A15	BUILDING 1 ELECTRICAL LAYOUT	1-E2	BUILDING 53 ELECTRICAL LAYOUT	53-E12	ASBESTOS ABATEMENT PLAN	HA-01
BUILDING 10 EXISTING/PROPOSED FLOOR PLANS	10-A1	BUILDING 53 EXISTING/PROPOSED FLOOR PLANS	53-A16	BUILDING 1 ELECTRICAL LAYOUT	1-E3	BUILDING 53 ELECTRICAL LAYOUT	53-E13		
BUILDING 10 EXISTING/PROPOSED FLOOR PLANS	10-A2	BUILDING 53 EXISTING/PROPOSED FLOOR PLANS	53-A17	BUILDING 1 ELECTRICAL LAYOUT	1-E4	BUILDING 57 ELECTRICAL LAYOUT	57-E1		
BUILDING 10 EXISTING/PROPOSED FLOOR PLANS	10-A3	BUILDING 53 EXISTING/PROPOSED FLOOR PLANS	53-A18	BUILDING 1 ELECTRICAL LAYOUT	1-E5	BUILDING 57 ELECTRICAL LAYOUT	57-E2		

#### CONSULTANTS:

#### ARCHITECT/ENGINEERS:

WATSON ENGINEERING, PC  
1112 STATE ROUTE 434  
OWEGO, NY 13827



#### Drawing Title

REPLACE B-1 PLUMBING  
100% SUBMISSION

#### Approved: Project Director

#### Project Title

REPLACE B-1 PLUMBING  
CONTRACT NO. VA243-16-C-0007  
LYONS NEW JERSEY VA CAMPUS

#### Location

NEW JERSEY LYONS CAMPUS VA LYONS, NJ

#### Date

2/15/17

#### Checked

BMW

#### Drawn

CJO

#### Project Number

561A4-14-108

#### Building Number

#### Drawing Number

T1

#### Dwg. of

Office of  
Construction  
and Facilities  
Management

